


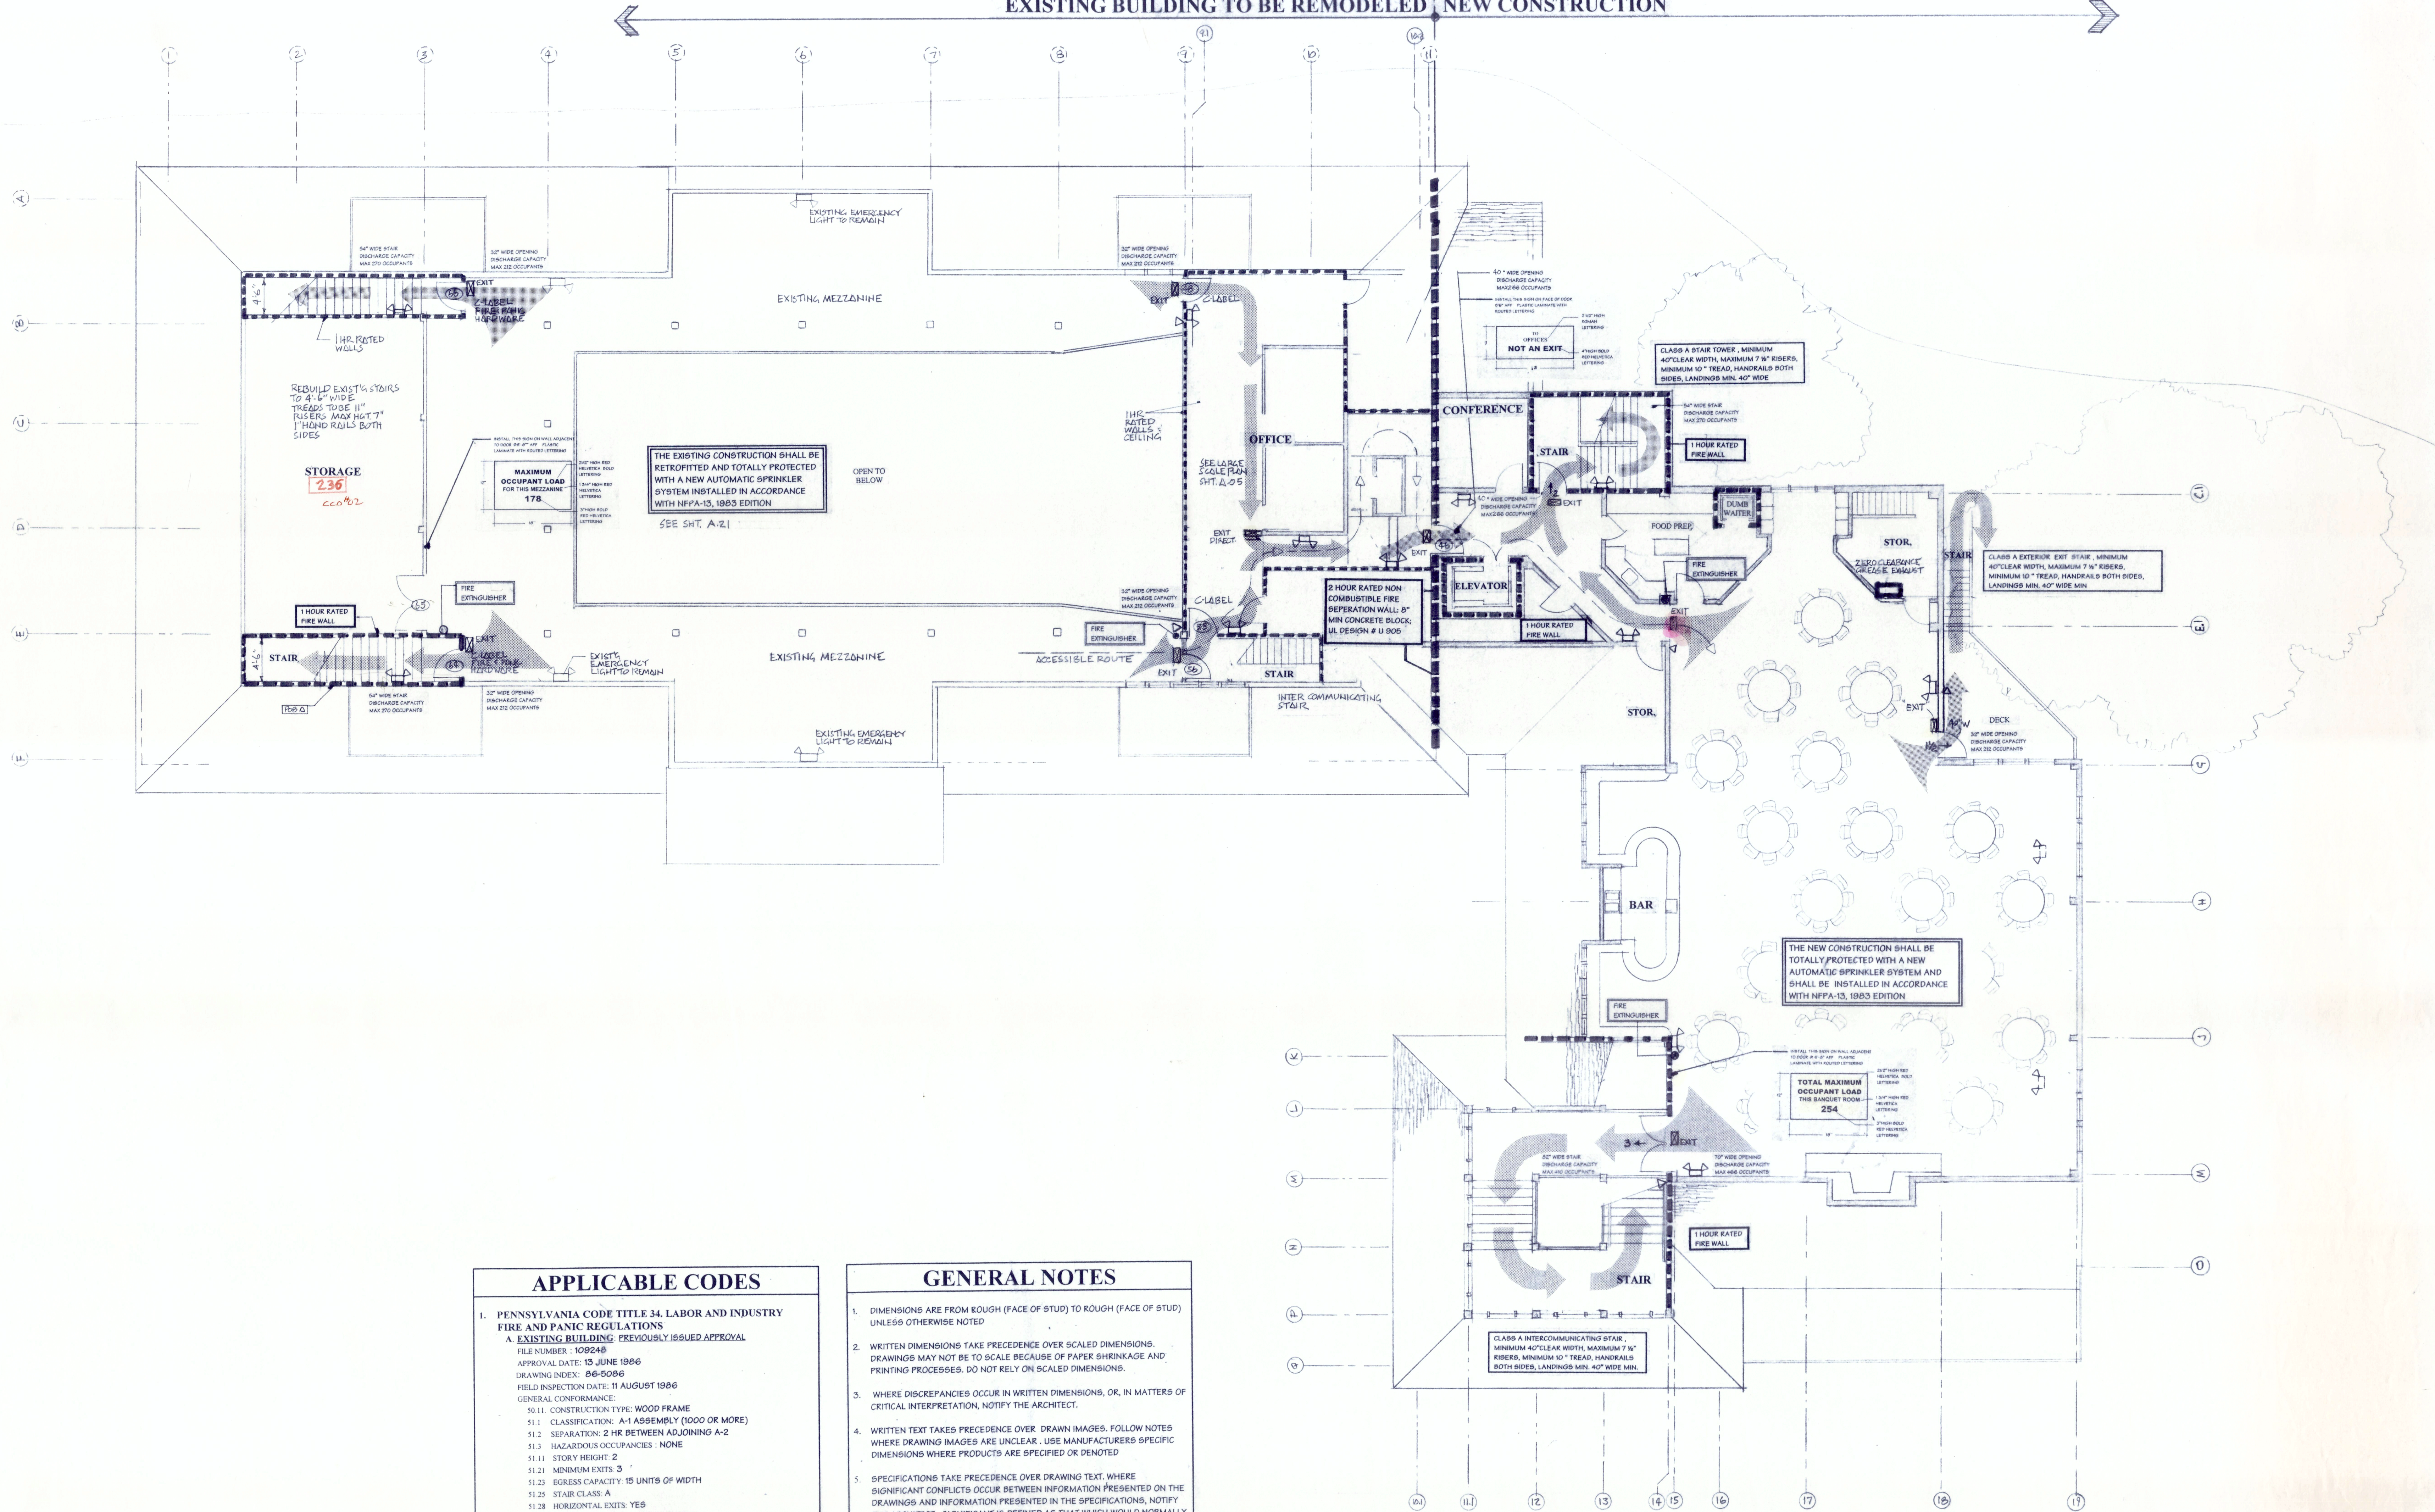

APPLICABLE CODES

- PENNSYLVANIA CODE TITLE 34. LABOR AND INDUSTRY FIRE AND PANIC REGULATIONS
 - EXISTING BUILDING: PREVIOUSLY ISSUED APPROVAL

FILE NUMBER: 109248
APPROVAL DATE: 13 JUNE 1996
DRAWING INDEX: 86-5086
FIELD INSPECTION DATE: 11 AUGUST 1986
GENERAL CONFORMANCE:


50.11. CONSTRUCTION TYPE: WOOD FRAME
51.1 CLASSIFICATION: A-1 ASSEMBLY (1000 OR MORE)
51.2 SEPARATION: 2 HR BETWEEN ADJOINING A-2
51.3 HAZARDOUS OCCUPANCIES: NONE
51.11 STORY HEIGHT: 2
51.21 MINIMUM EXITS: 3
51.23 EGRESS CAPACITY: 15 UNITS OF WIDTH
51.25 STAIR CLASS: A
51.28 HORIZONTAL EXITS: YES
51.51 FIRE ALARM SYSTEM: NOT REQUIRED
51.61 EMERGENCY LIGHTING: SEE ELECTRICAL PLANS
51.71 FIRE EXTINGUISHERS: 2 PER FLOOR
51.72 AUTOMATIC SPRINKLER SYSTEM: YES, NEW
51.81 HAZARDOUS AREAS: NONE
 - NEW BUILDING: USE: DINING

FILE NUMBER:
APPROVAL DATE:
DRAWING INDEX:
FIELD INSPECTION DATE:
GENERAL CONFORMANCE:

50.11. CONSTRUCTION TYPE: WOOD FRAME
51.1 CLASSIFICATION: A-2 ASSEMBLY (101 TO 500 persons)
51.2 SEPARATION: 2 HR BETWEEN ADJOINING A-1
51.3 HAZARDOUS OCCUPANCIES: NONE
51.11 STORY HEIGHT: 2
51.21 MINIMUM EXITS: 2
51.23 EGRESS CAPACITY: 17 UNITS OF WIDTH
51.25 STAIR CLASS: A
51.28 HORIZONTAL EXITS: YES
51.51 FIRE ALARM SYSTEM: NOT REQUIRED
51.61 EMERGENCY LIGHTING: SEE ELECTRICAL PLANS
51.71 FIRE EXTINGUISHERS: 2 PER FLOOR, 1 KITCHEN TOP
51.72 AUTOMATIC SPRINKLER SYSTEM: YES
51.81 HAZARDOUS AREAS: BOILER ROOM
- THE BOCA NATIONAL FIRE PREVENTION CODE 1996
- THE AMERICANS WITH DISABILITIES ACT ACCESSIBILITY GUIDELINES
- THE ORDINANCES OF LOGAN TOWNSHIP PENNSYLVANIA

GENERAL NOTES

- DIMENSIONS ARE FROM ROUGH (FACE OF STUD) TO ROUGH (FACE OF STUD) UNLESS OTHERWISE NOTED
- WRITTEN DIMENSIONS TAKE PRECEDENCE OVER SCALED DIMENSIONS. DRAWINGS MAY NOT BE TO SCALE BECAUSE OF PAPER SHRINKAGE AND PRINTING PROCESSES. DO NOT RELY ON SCALED DIMENSIONS.
- WHERE DISCREPANCIES OCCUR IN WRITTEN DIMENSIONS, OR, IN MATTERS OF CRITICAL INTERPRETATION, NOTIFY THE ARCHITECT.
- WRITTEN TEXT TAKES PRECEDENCE OVER DRAWN IMAGES. FOLLOW NOTES WHERE DRAWING IMAGES ARE UNCLEAR. USE MANUFACTURERS SPECIFIC DIMENSIONS WHERE PRODUCTS ARE SPECIFIED OR DENOTED
- SPECIFICATIONS TAKE PRECEDENCE OVER DRAWING TEXT. WHERE SIGNIFICANT CONFLICTS OCCUR BETWEEN INFORMATION PRESENTED ON THE DRAWINGS AND INFORMATION PRESENTED IN THE SPECIFICATIONS, NOTIFY THE ARCHITECT. SIGNIFICANT IS DEFINED AS THAT WHICH WOULD NORMALLY NOT BE CONSIDERED A MINOR ADJUSTMENT.
- FIELD VERIFY ALL DIMENSIONS. ACTUAL WRITTEN DIMENSIONS MAY REQUIRE FIELD ADJUSTMENT DO TO CONSTRUCTION TOLERANCES AND MATERIAL SIZES. USE ACTUAL DIMENSIONS AS REQUIRED WHERE THE WORDS "CLEAR", "MIN" ("MINIMUM"), OR "MAX" ("MAXIMUM") ACCOMPANY THE DIMENSION.
- CONSTRUCTION COMPONENTS WHICH ARE CLEARLY INDICATED, ON THE DRAWINGS, BUT, WHICH LACK FURTHER SPECIFICATION, DETAIL OR BID ALLOWANCE, SHALL BE PROVIDED THE MAXIMUM (OR ARCHITECTURAL GRADE) PRICE ALLOWANCE ACCORDING TO THE MOST RECENT EDITION OF "MEANS" COST DATA". THESE ALLOWANCES SHALL BE PRESENTED AS A CUMULATIVE LIST, TO THE OWNER, AT THE BID OPENING ALONG WITH ANY OTHER ALLOWANCES SO INDICATED HERE-IN. (EXAMPLE: WOOD RAILINGS, NO DESIGN, ALLOW MAX \$44 PER LIN. FT.)
- THE CONTRACTOR SHALL BE RESPONSIBLE FOR SECURING ANY AND ALL BUILDING PERMITS REQUIRED
- COORDINATE ALL CONSTRUCTION WITH OWNERS APPOINTED VENDORS REQUIRING SERVICE LINES SUCH AS CONDUIT, COMMUNICATION WIRING, FLUID PIPING, (I.E. BEER AND SODA DISPENSER PIPING).

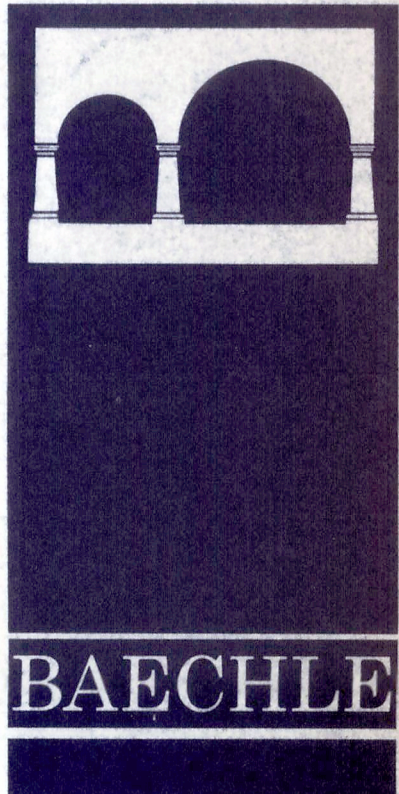

Baechle & Associates


ARCHITECTS
A. I. A.

408 UNION STREET
HOLLIDAYSBURG
PENNSYLVANIA

814 - 696 - 7506

10/25/97	GC REVIEW
11/02/97	ISSUE
03/04/98	REVISED
13/04/98	PERMIT
16/07/98	CONTRACT

ADDITIONS AND ALTERATIONS TO
THE CASINO
AT LAKE MONT PARK
300 Lakemont Park Blvd., Altoona, Pennsylvania

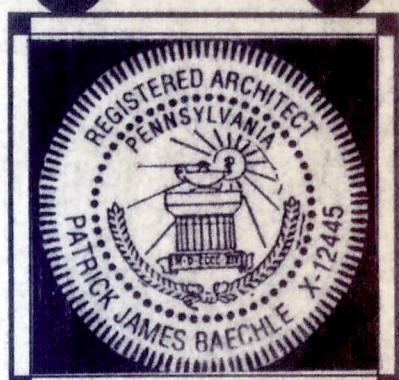

JOB	961107c
SCALE	1/8"=1'-0"
DATE	16 OCT 98

SECOND FLOOR PLAN
1/8 SCALE
GENERAL INFO
LIFE SAFETY
ACCESSIBILITY